




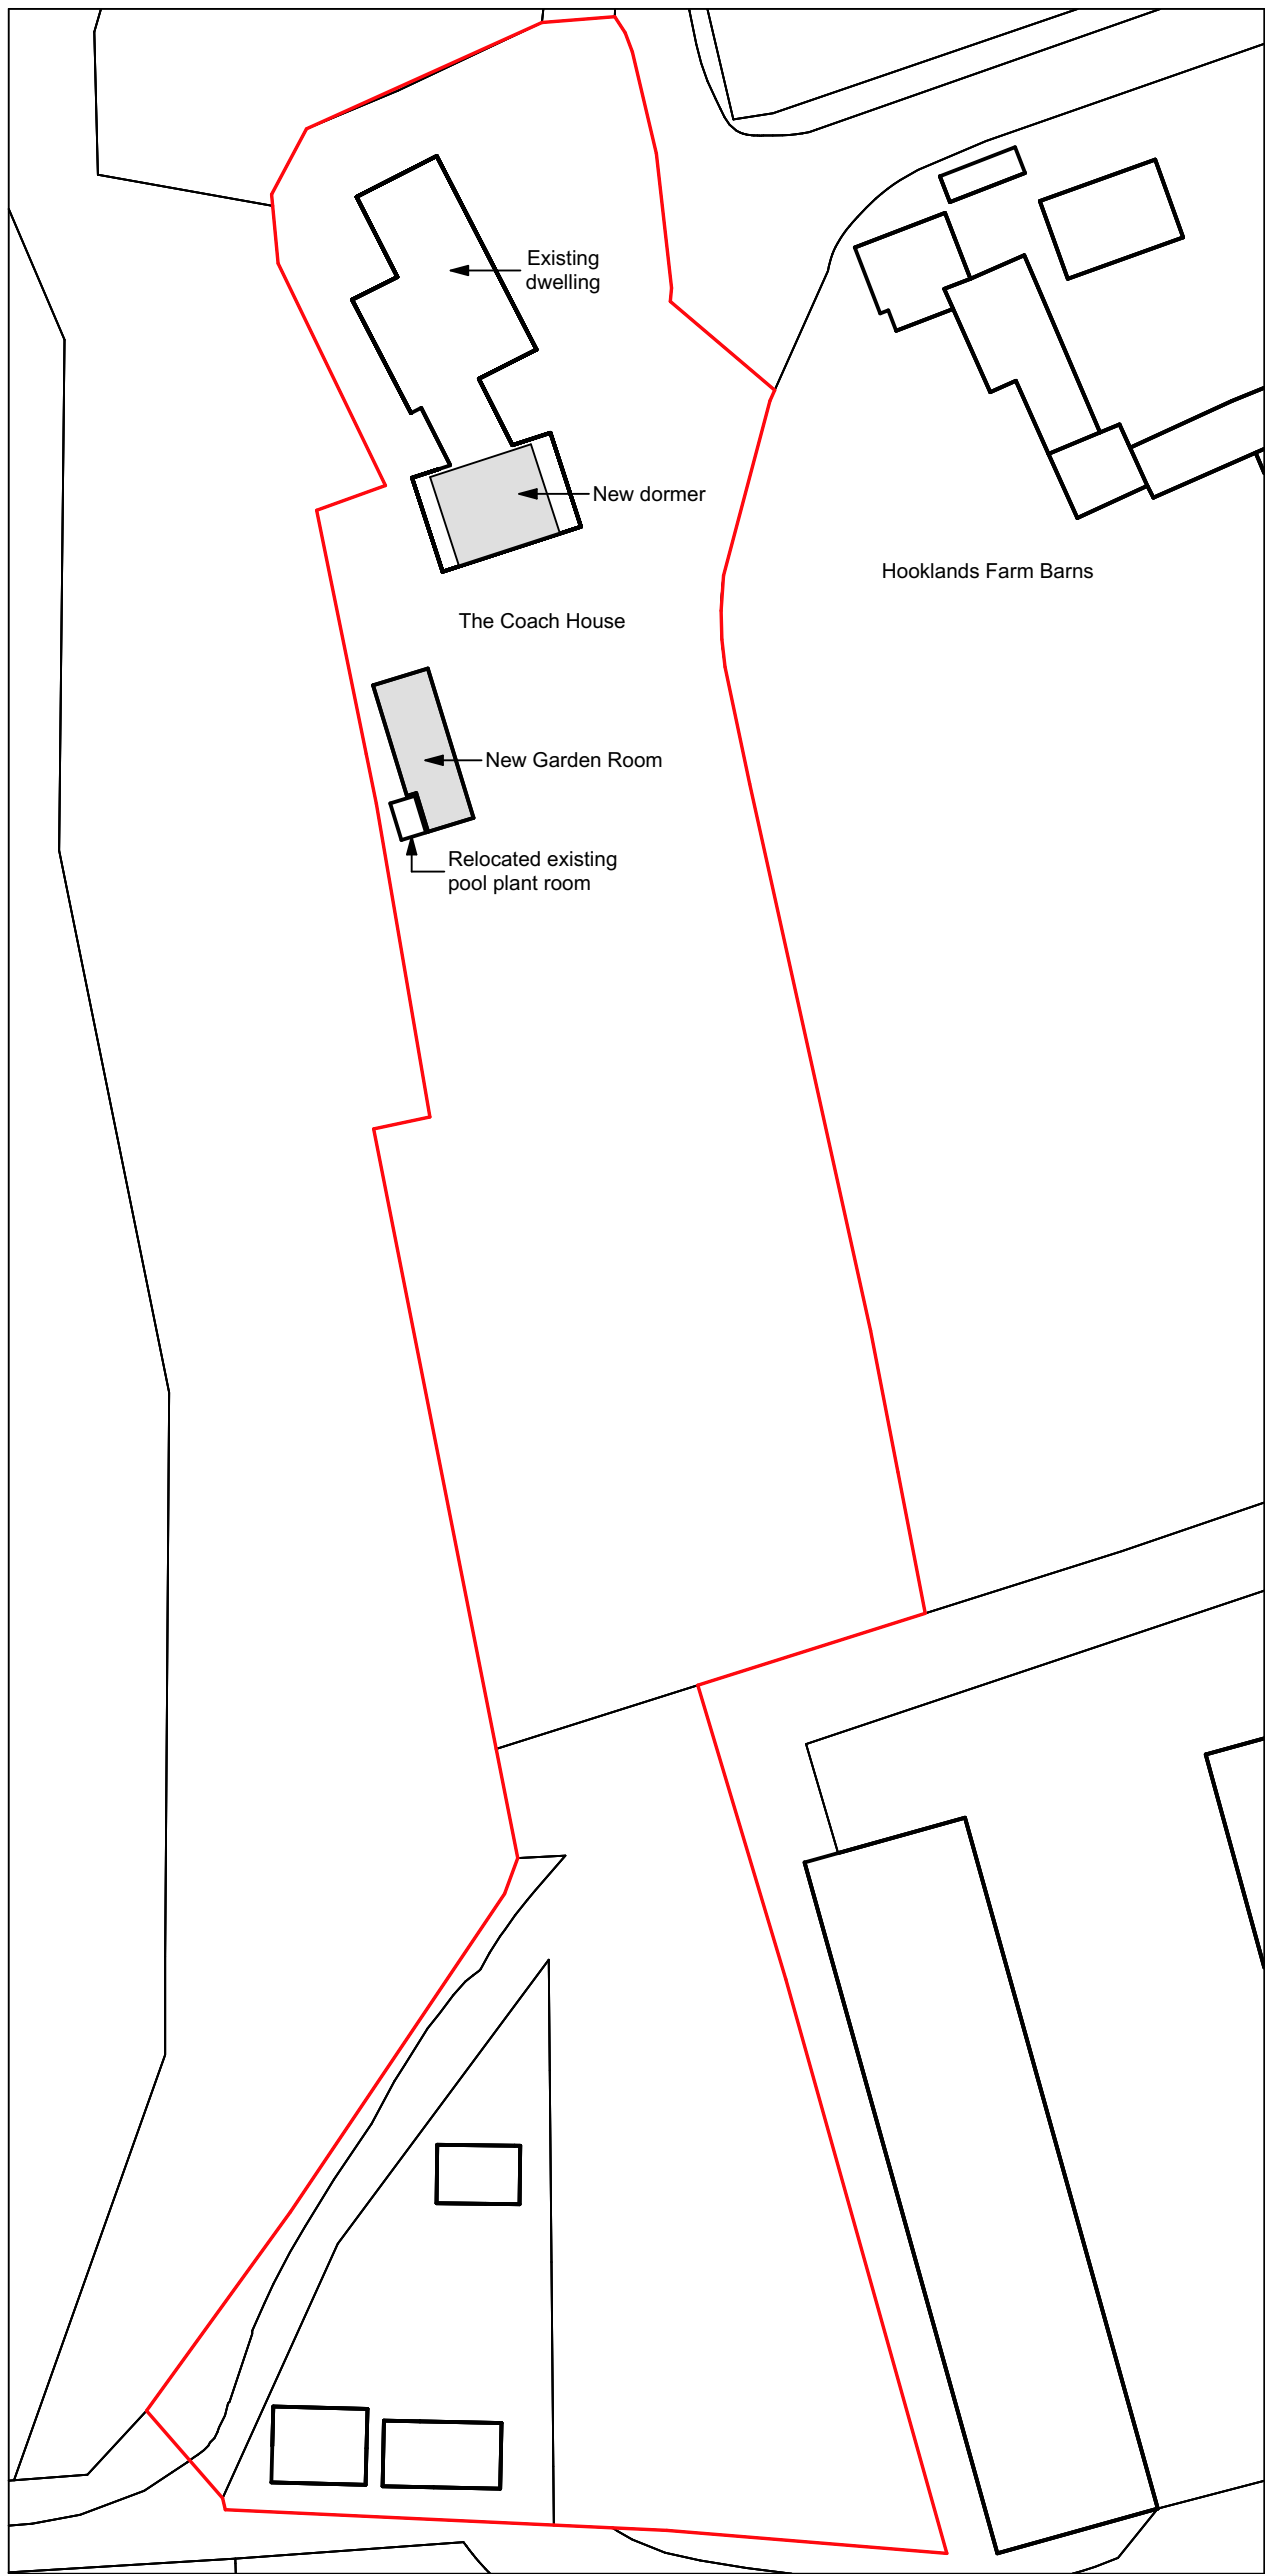

Proposed Site Block Plan 1:500

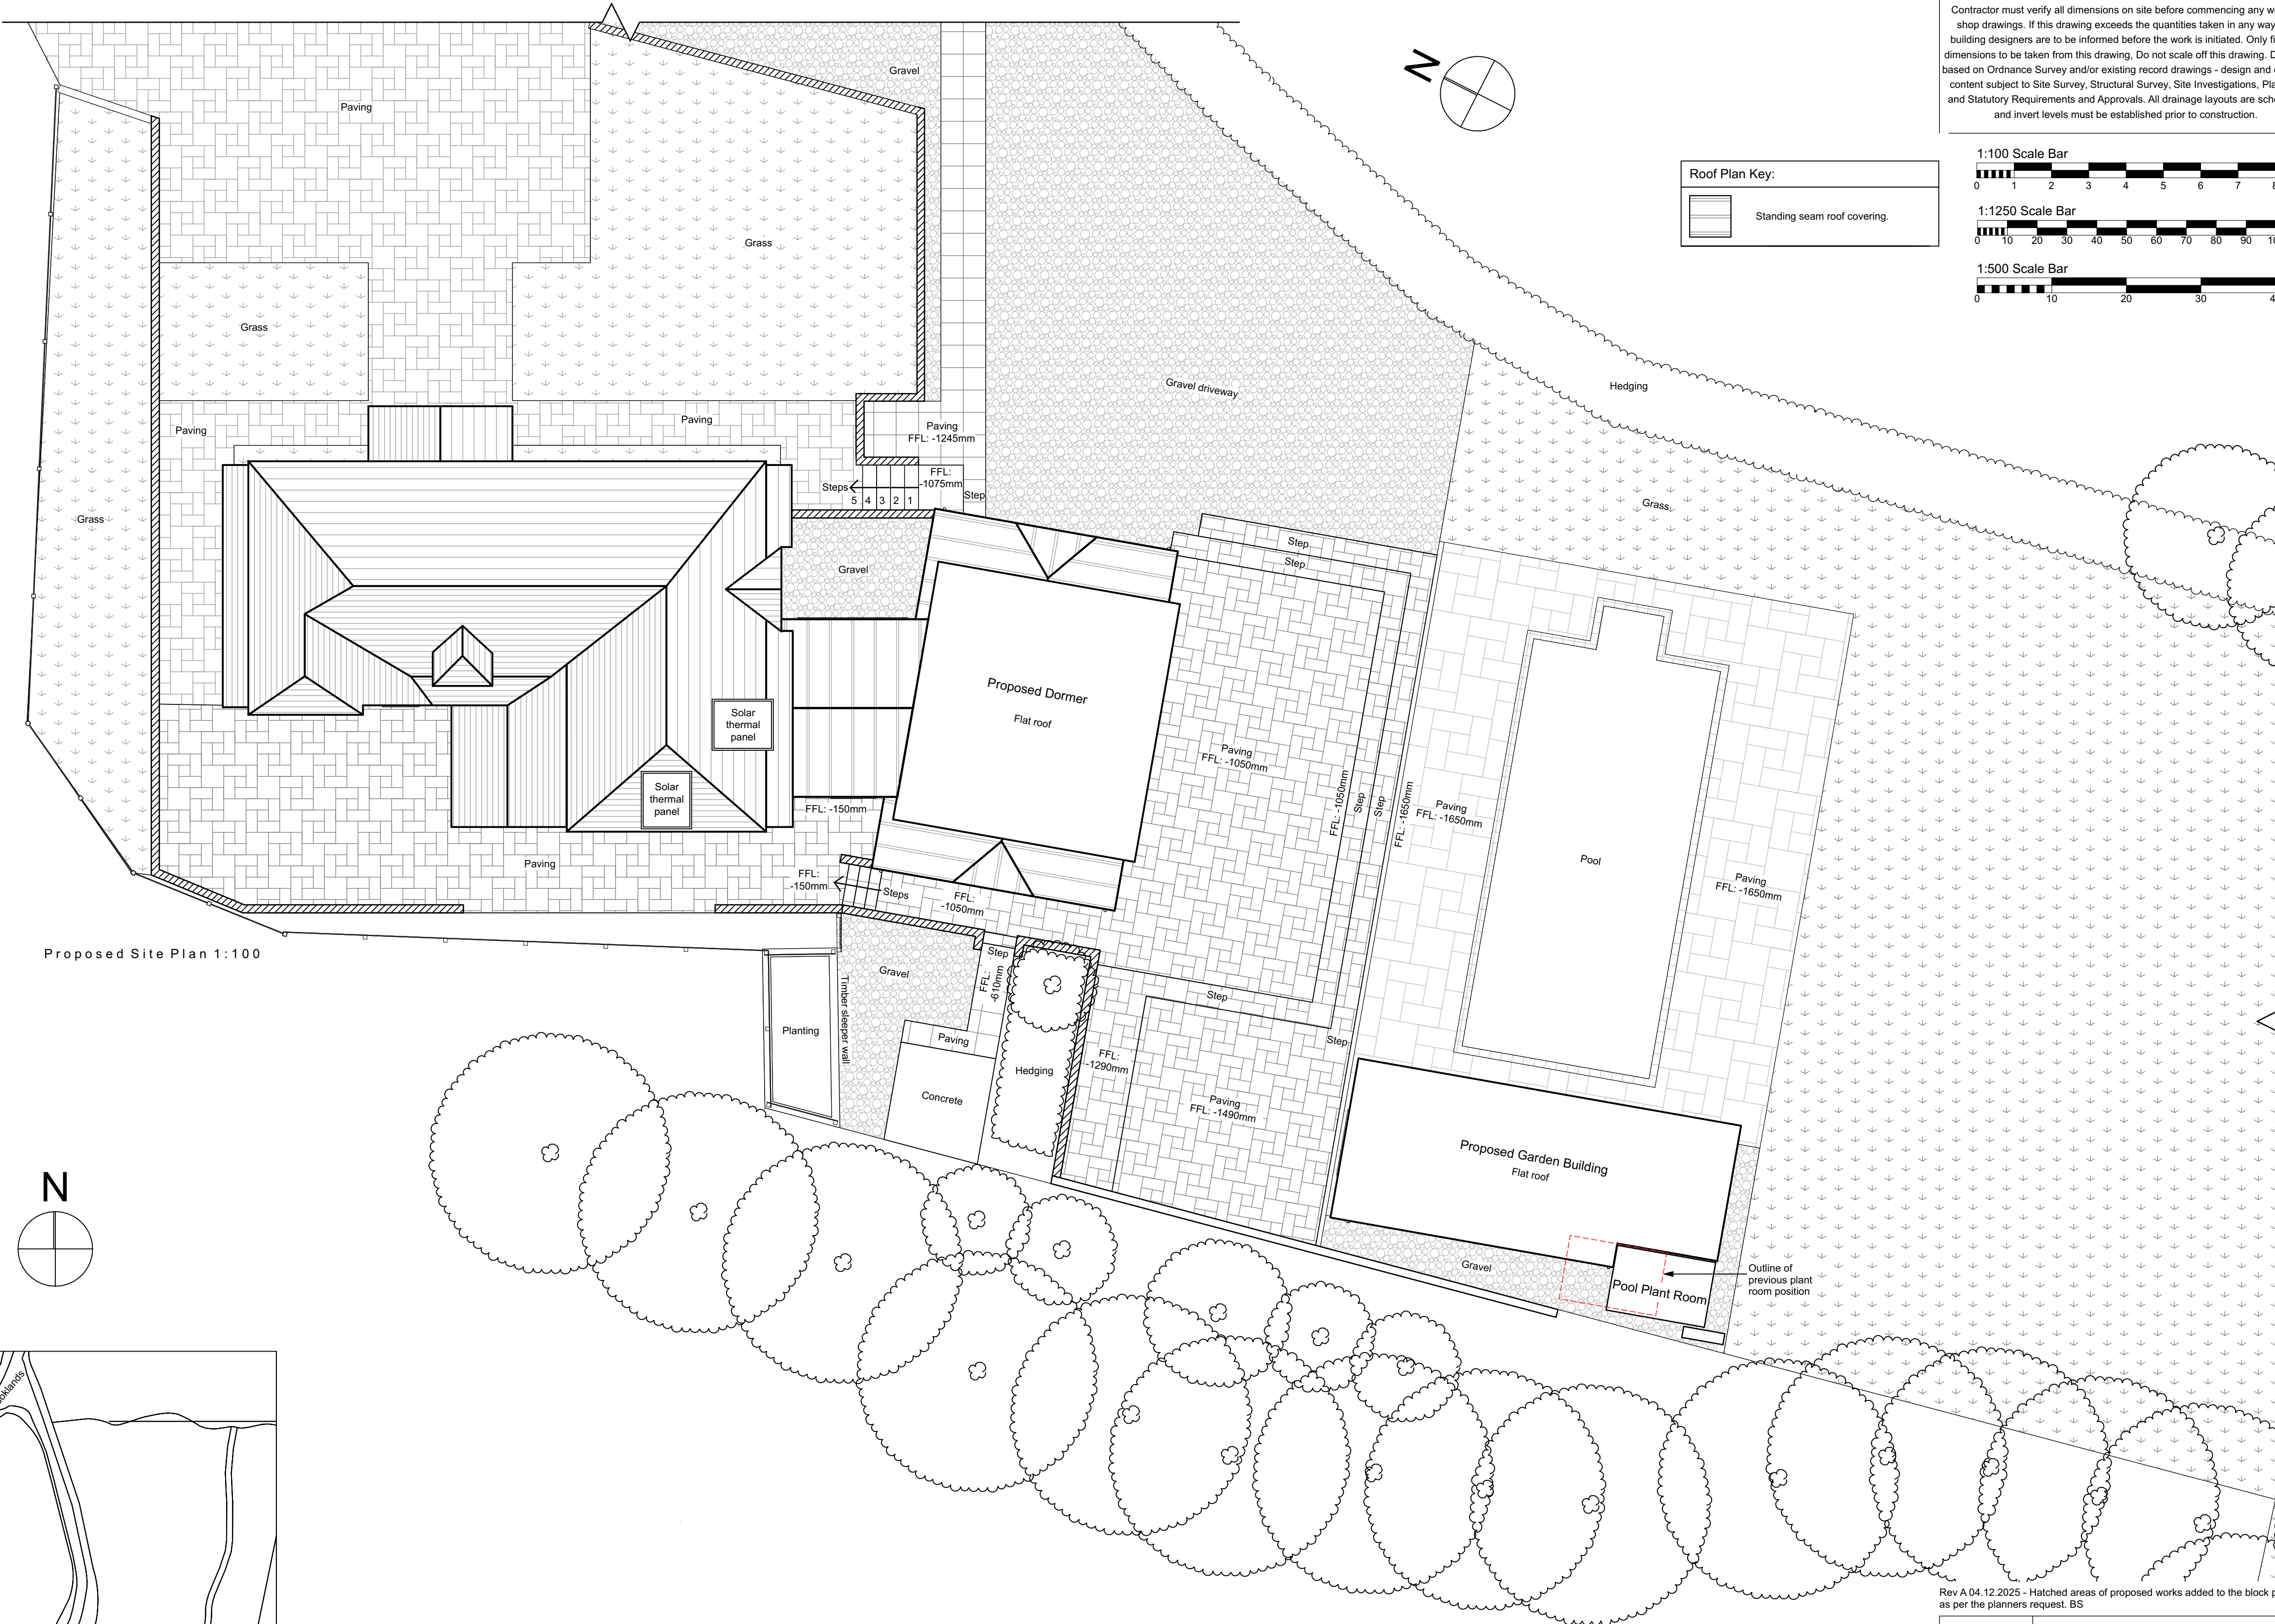


Proposed Site Plan 1:100

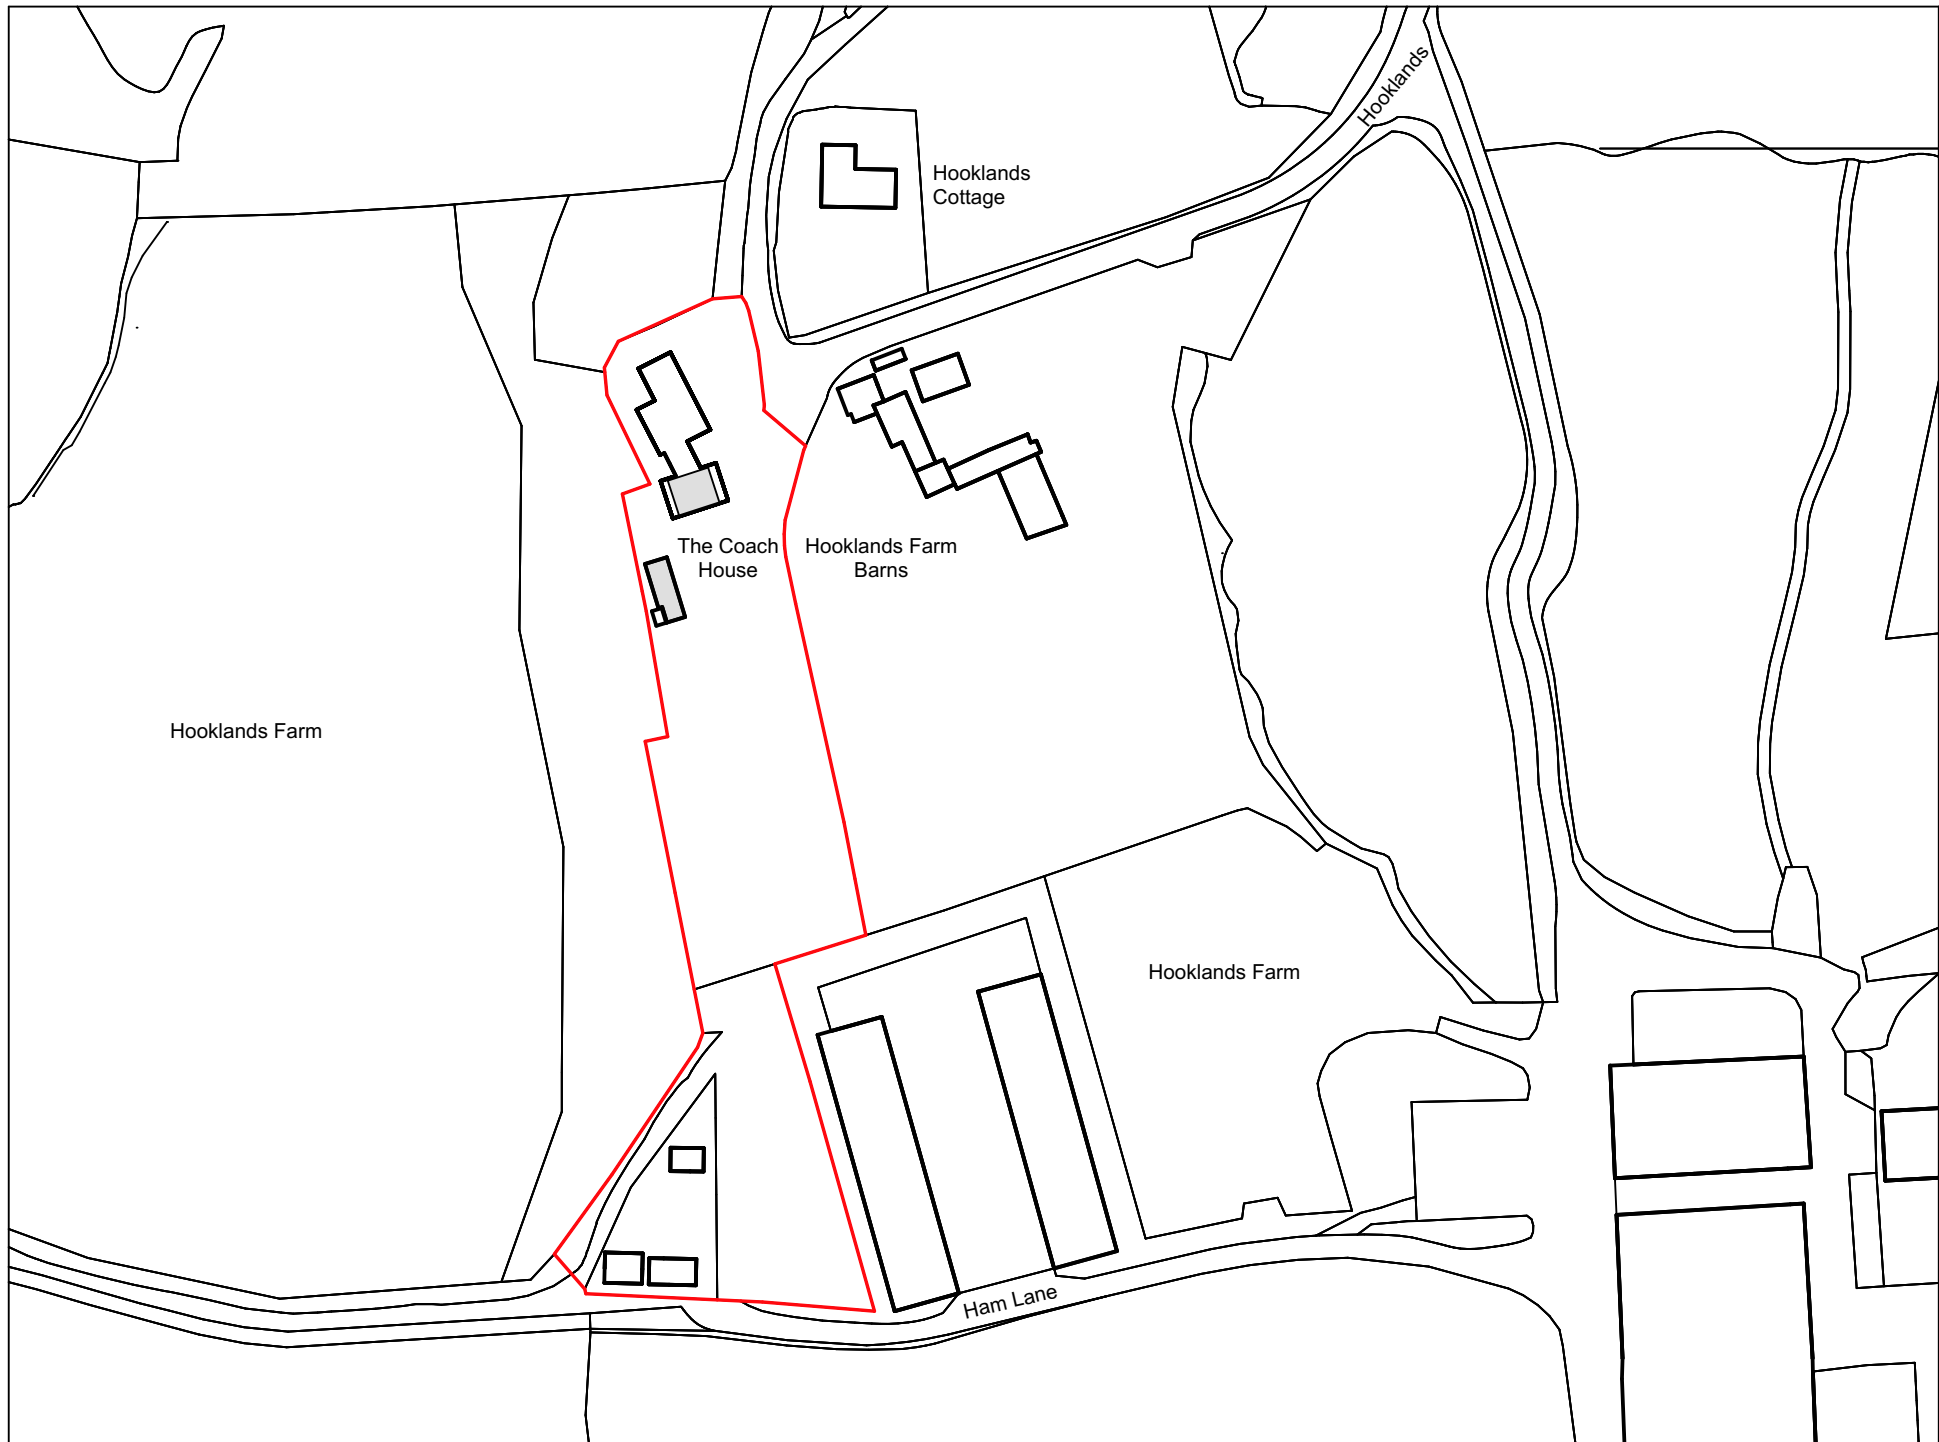

Proposed Site Location Plan 1:1250

Contractor must verify all dimensions on site before commencing any work or shop drawings. If this drawing exceeds the quantities taken in any way, the building designers are to be informed before the work is initiated. Only figured dimensions to be taken from this drawing. Do not scale off this drawing. Drawing based on Ordnance Survey and/or existing record drawings - design and drawing content subject to Site Survey, Structural Survey, Site Investigations, Planning and Statutory Requirements and Approvals. All drainage layouts are schematic and invert levels must be established prior to construction.

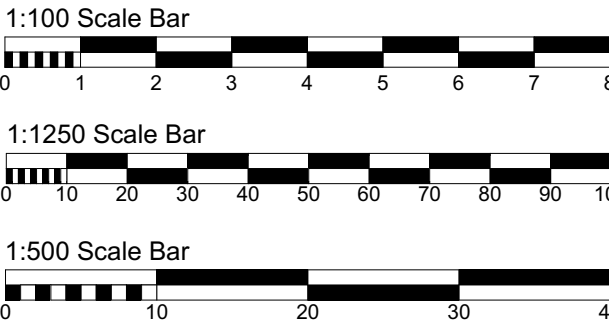

Rev A 04.12.2025 - Hatched areas of proposed works added to the block plan as per the planners request. BS

Project Status:	PLANNING ONLY
TransformARCHITECTS	
4 Rushmead Court, Ossett, WF5 0NZ tel: 01924 275 594 web: www.transformarchitects.co.uk email: info@transformarchitects.co.uk	
Project Address:	The Coach House, Hooklands Farm, Lewes Road, Haywards Heath, RH17 7NG
Client:	Mr & Mrs Thickett
Drawing Title:	Proposed Site Plan A1
Scale:	1:100, 1:1250, 1:500
Date:	24.11.2025
Drawn By:	MNB
Drawing Number:	T1290 - PL04
Revision:	Rev A