




THIS DRAWING IS COPYRIGHT AND MUST NOT BE REPRODUCED IN WHOLE OR PART WITHOUT WRITTEN AUTHORITY

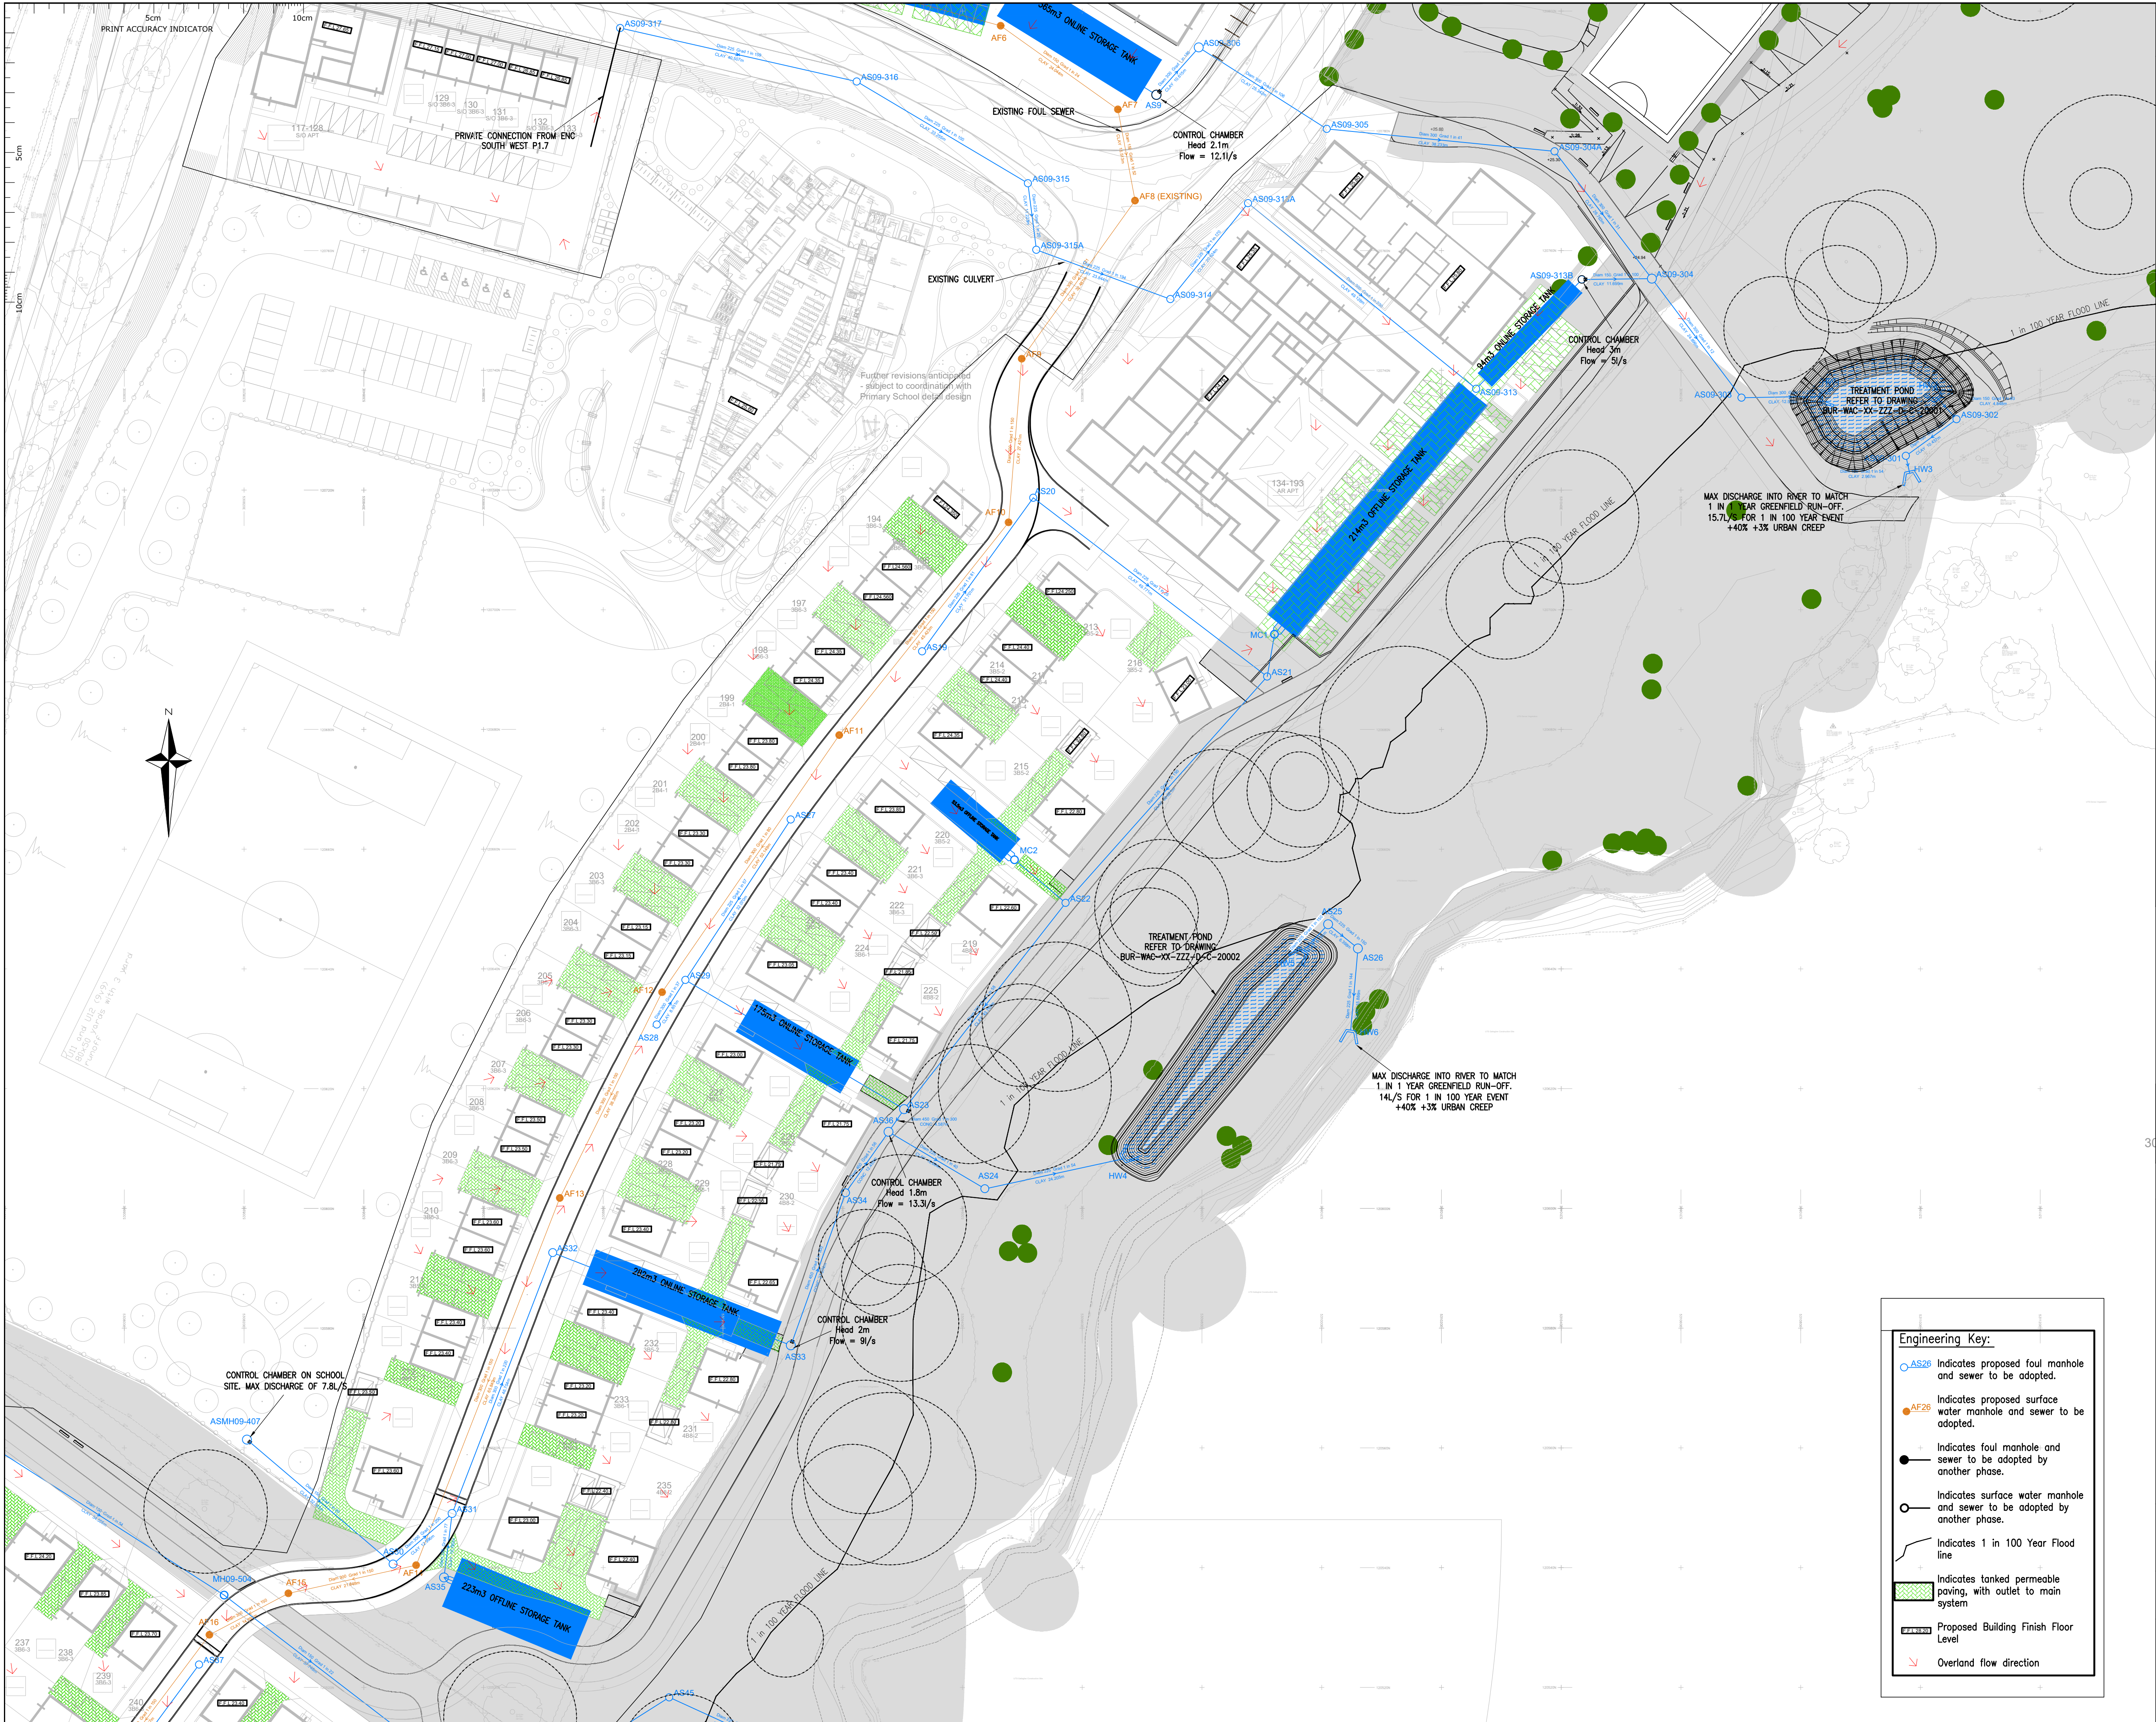

REV	DATE	AMENDMENT	BY	CHKD
P02	10/07/25	Start of road 1 re-designed again as per client request. House FFL's and drainage adjusted to suit. Treatment pond 1 moved back to original position.	AB	LWR

STATUS **PLANNING**

PROJECT
**Burgess Hill
Northern Arc
Phase 1C**
CLIENT



DRAWING
**Main Drainage Layout
Sheet 2**

DATE **02/06/2025** DRAWN BY **AB** REV.
SCALE (A1)- 1:500 CHECKED BY **LWR** **P02**
WALKERS JOB NUMBER **7714**

DRG NO.
BUR-WAC-ZZZ-00-D-C-10402

Walker Associates Consulting Limited
Structural and Civil Engineers
13 Capricorn Centre
Crane Farm Road
Basilston, Essex
SS14 3JF
01268 530 500
walker-associates.co.uk