
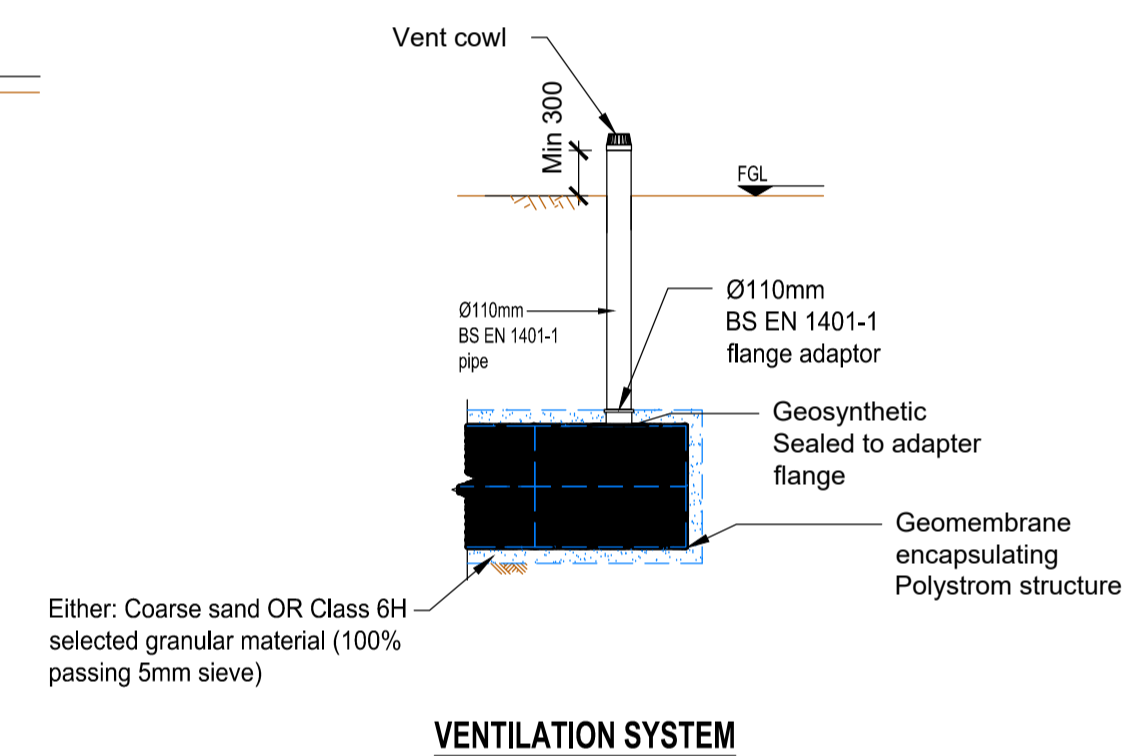
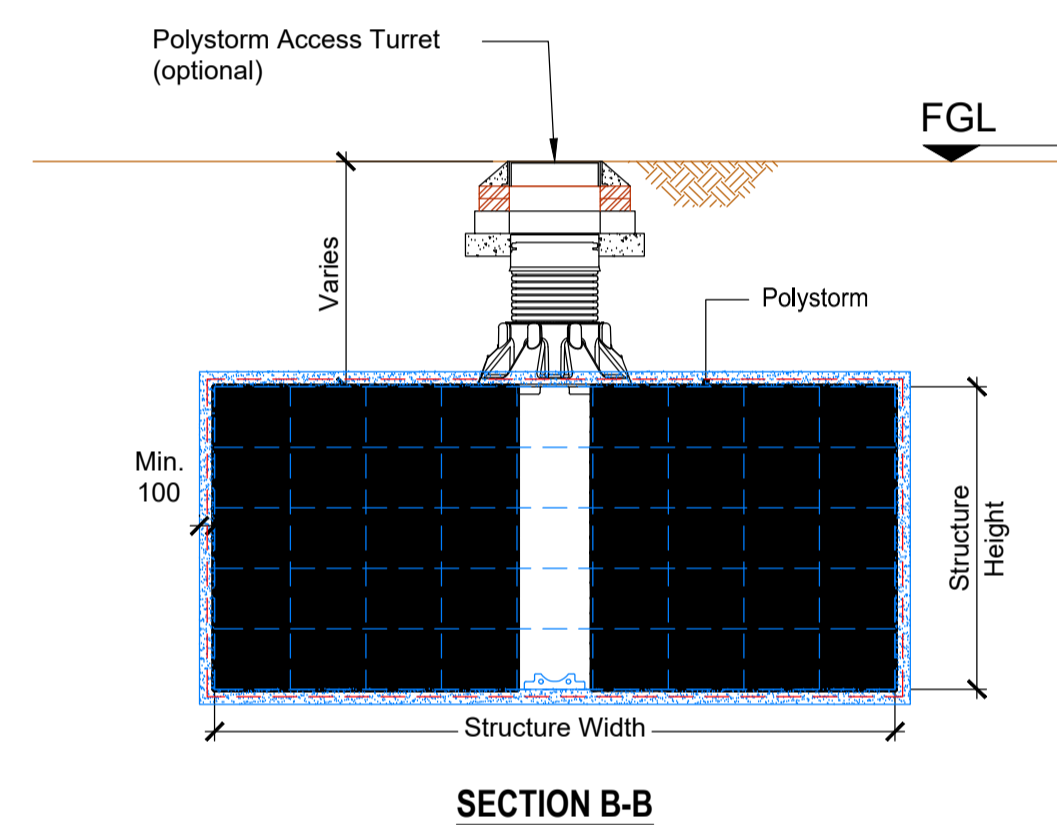
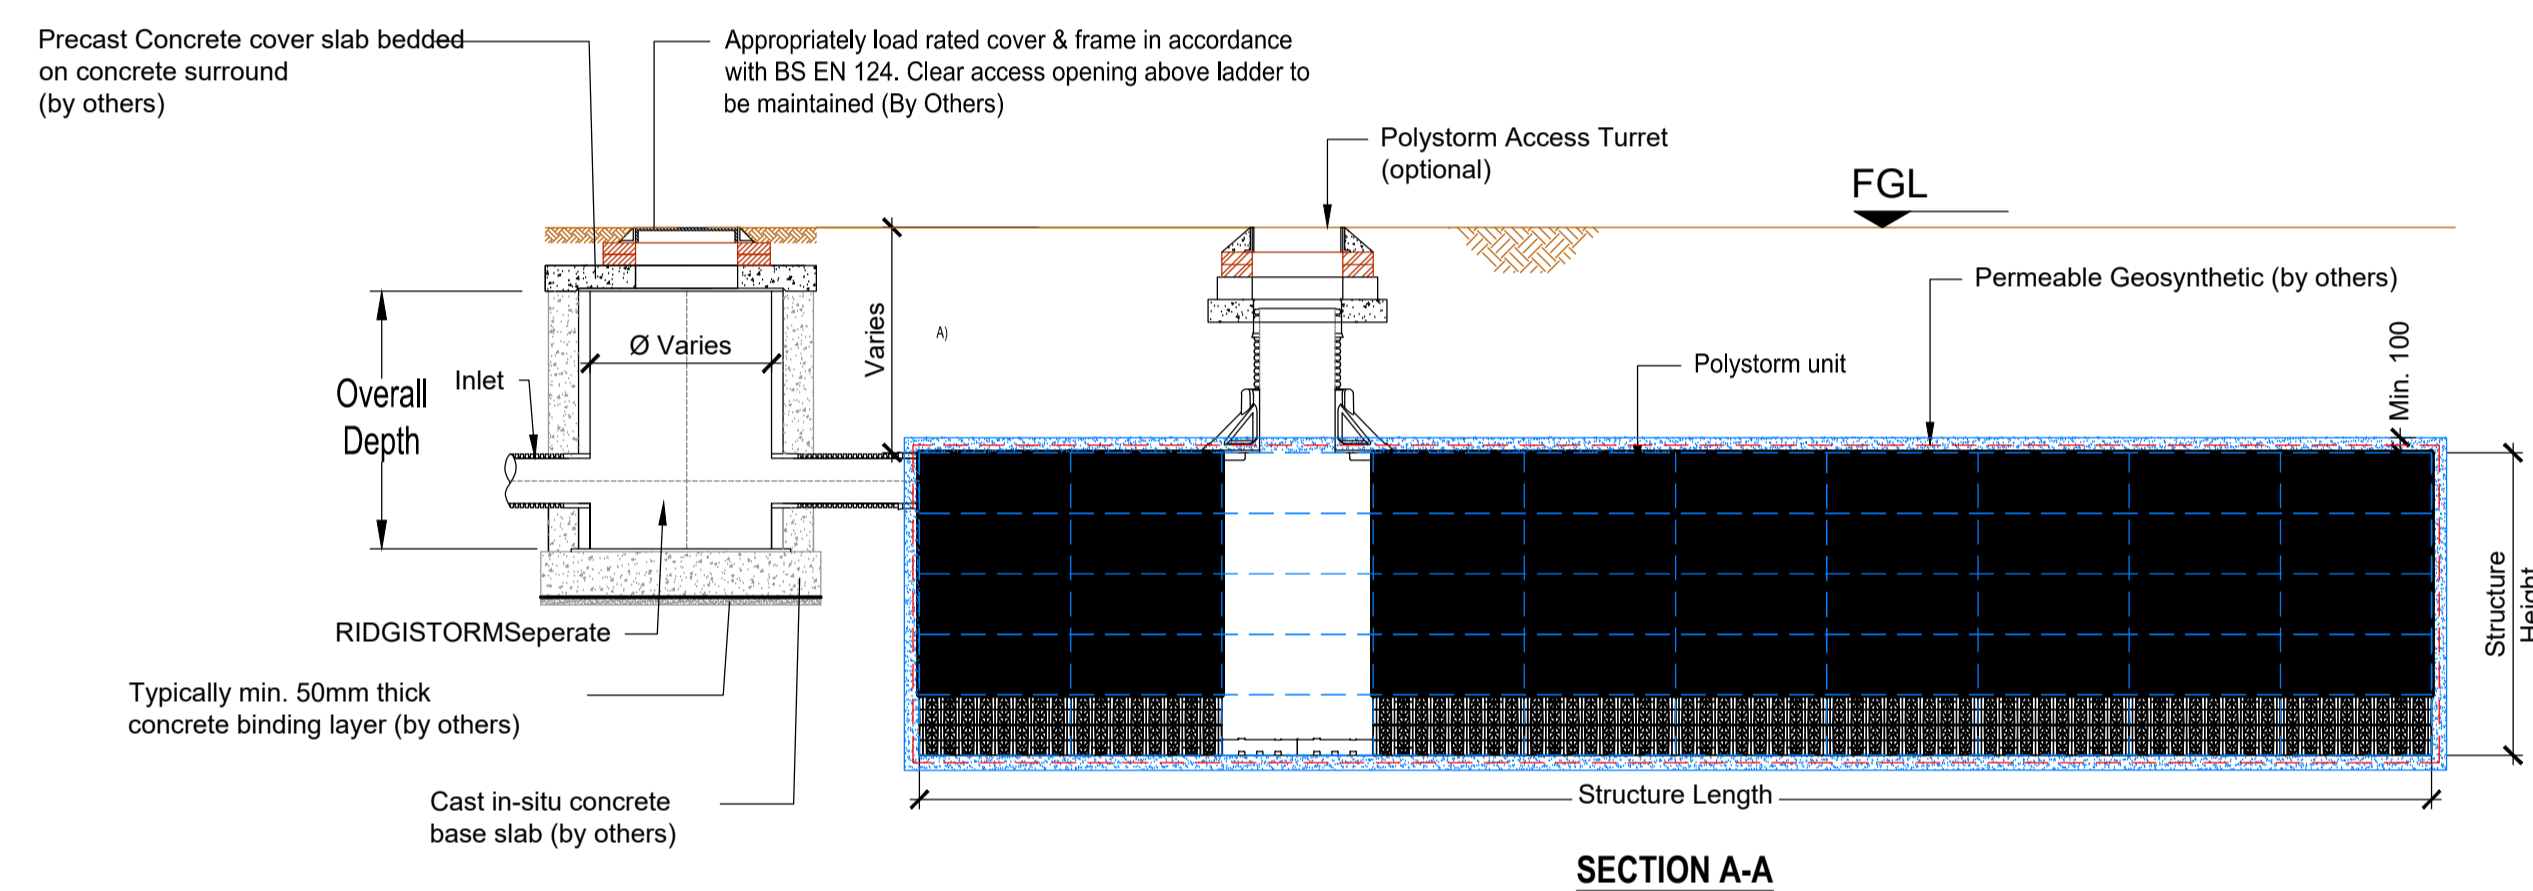


1. This drawing is to be read in conjunction with all relevant Architects, Engineers and other specialist details and specifications.
2. Do not scale from this drawing.
3. This drawing must be read in conjunction with drawing 0118-ACS-XX-XX-DP-C-9200 Proposed Drainage Layout.
4. Drawing issued for PRELIMINARY discussions only, further to approval from Planning, Local Authority, Sewerage Undertaker, Environment Agency and any other governing parties. Following receipt of further information and comments the scheme may be revised.

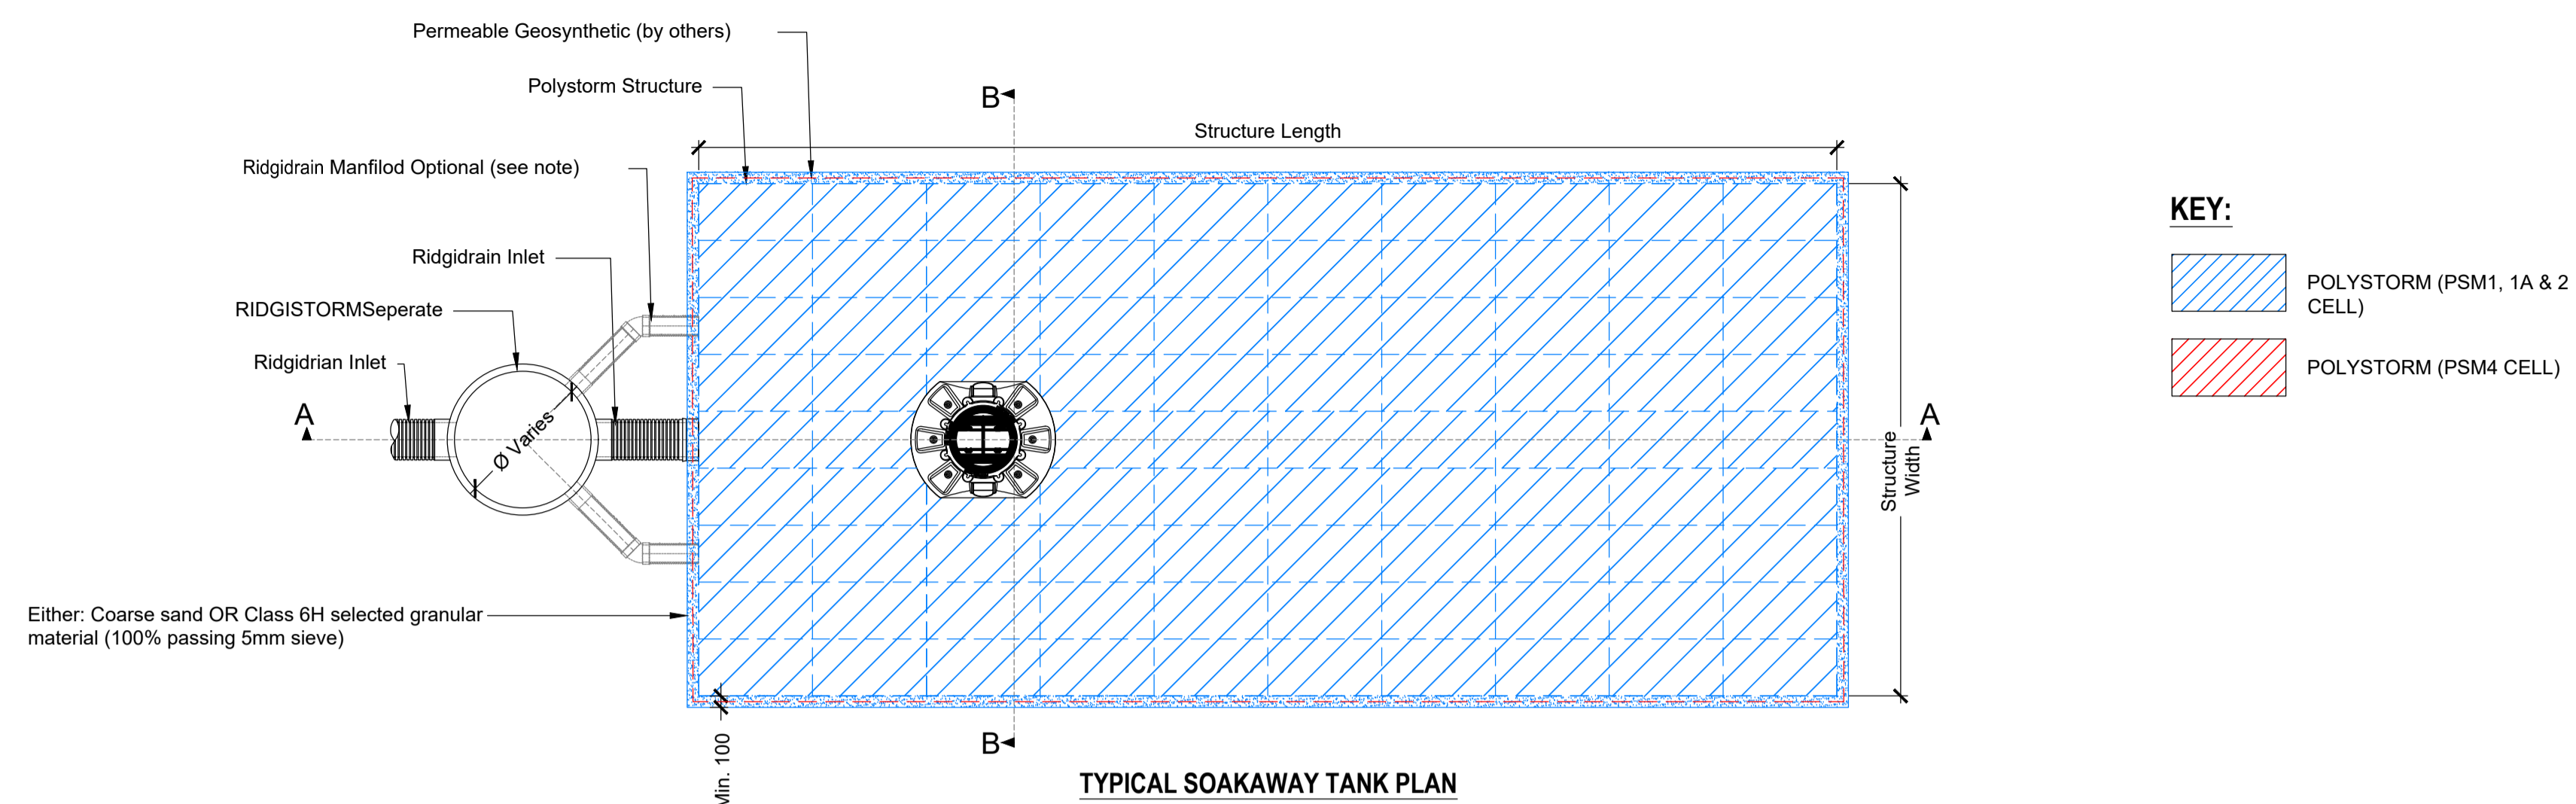

0 First Issue BS MF GP 18.12.24

Rev Description By Chk App Date

Purpose of Issue : Status Code :
WORK IN PROGRESS

ACIES
 an RSK company

LANCASTER HOUSE,
 67 NEWHALL STREET, BIRMINGHAM,
 B3 1NQ
 Tel : 0121 270 6962
 www.aciesgroup.co.uk

Client :
ATTP Architects + Building Surveyors
 Brook House Coventry Road Ilford Essex IG1 4QR
 T 020 8532 4141 F 020 8532 4140

Project : **Queensmere House
 East Grinstead**

Drawing : **Drainage Construction Details
 Sheet 2 of 2**

Acies Job No : 3470118 Scale @ A1 : AS Shown
 Drawing No : 0118-ACS-XX-XX-DD-9211 Rev : P01